


NOTES:

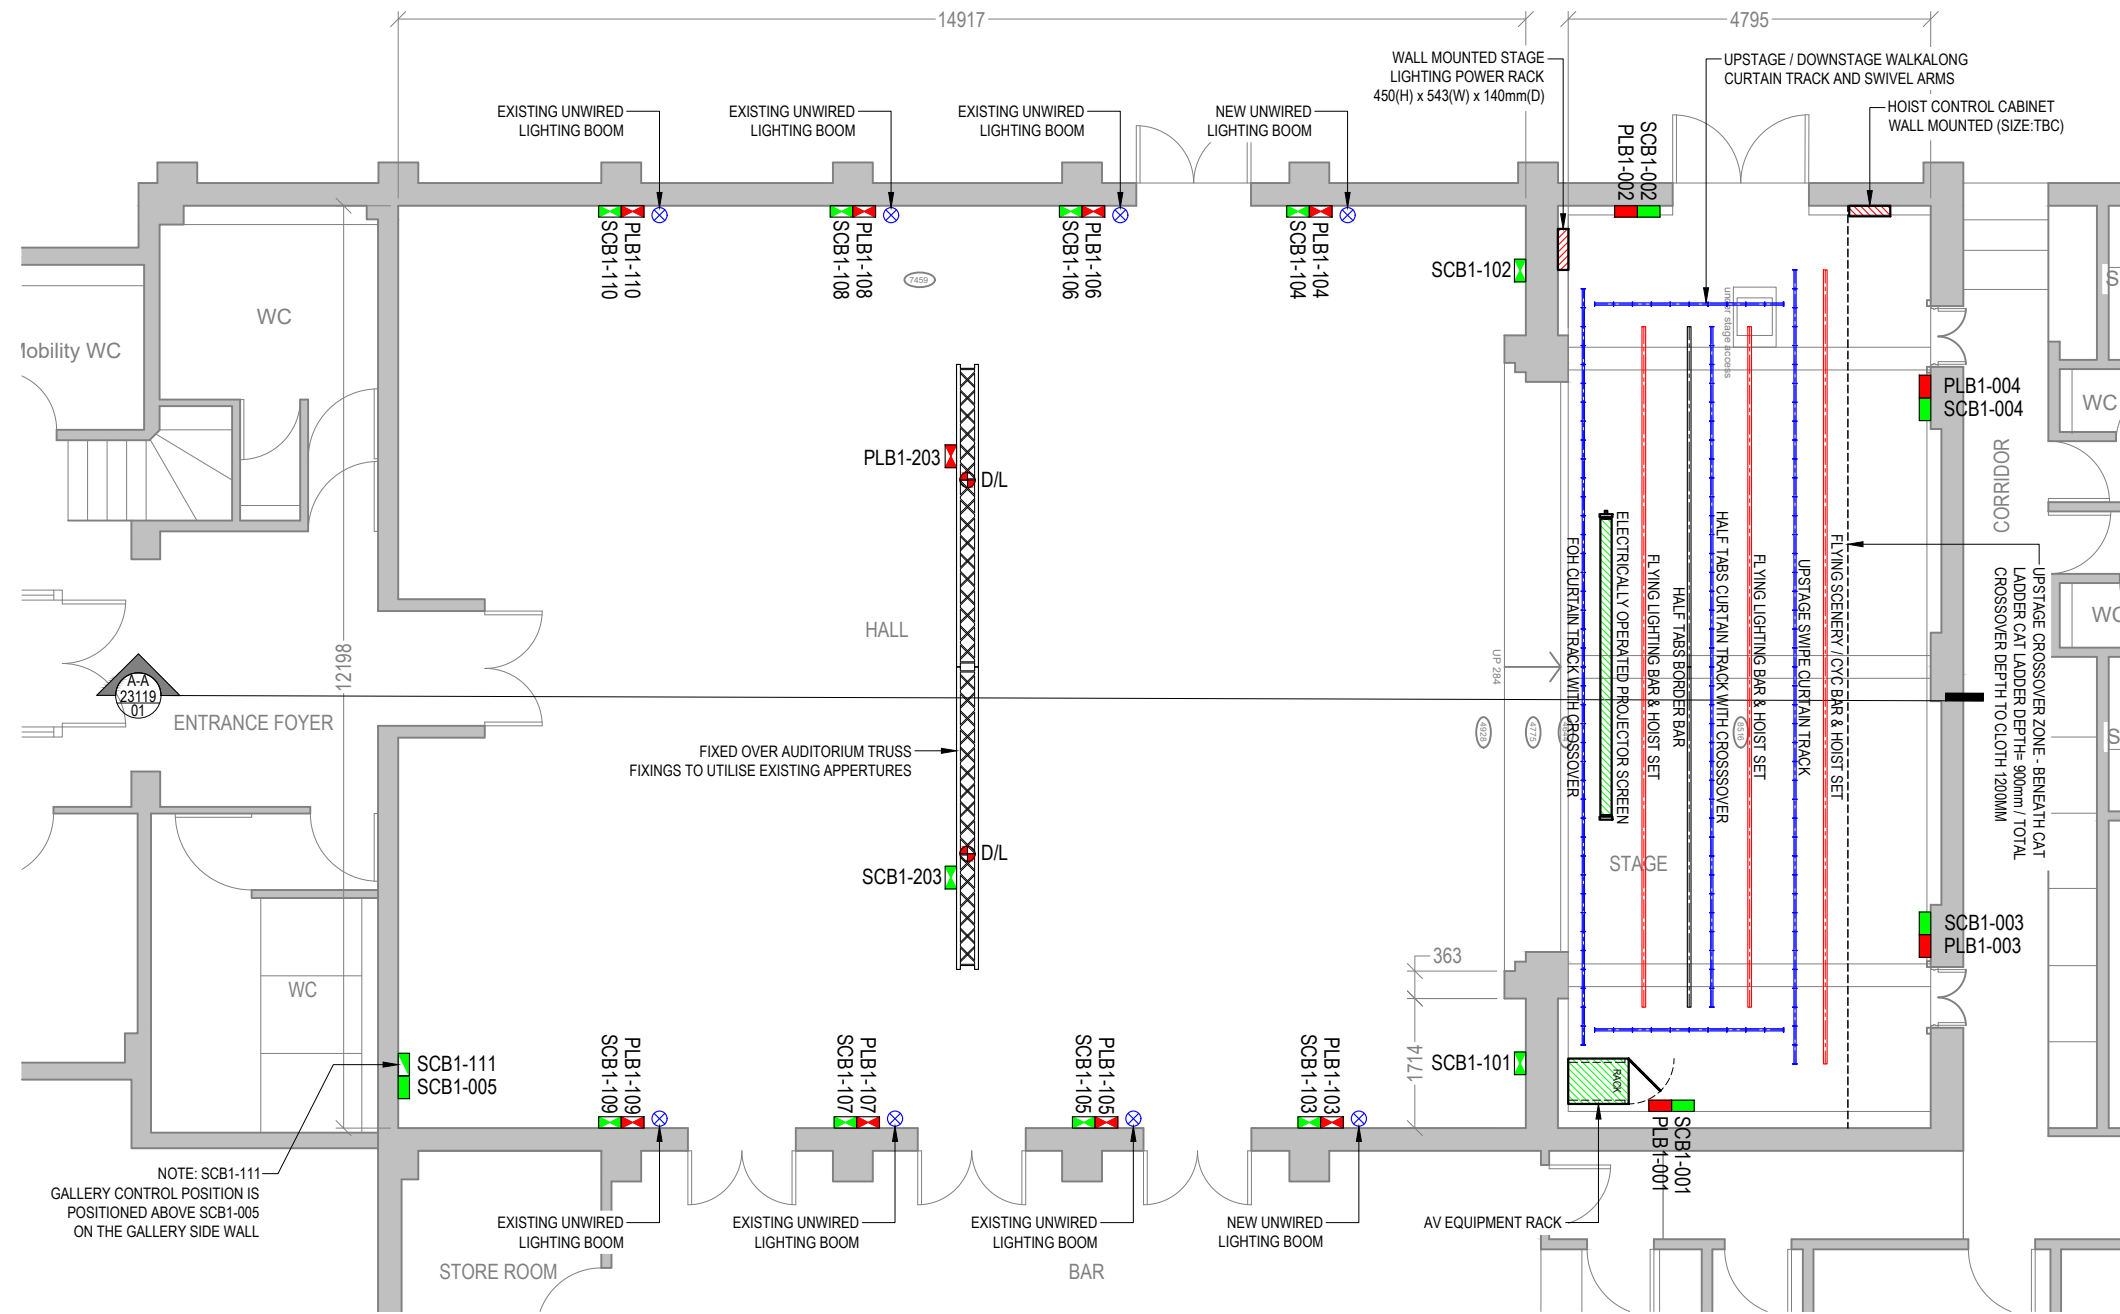

01 HALL & STAGE GROUND FLOOR OVERVIEW PLAN
1:100

DO NOT SCALE SHEET SIZE **A3**

KEYPLAN

DRAWING REFERENCES

Dwg No.	Rev	Title
24865-110	--	EXISTING FLOOR PLAN

LEGEND

■ AUDIOVISUAL FACILITY PANEL (SCB)	 LOW LEVEL 450AFFL
■ STAGE LIGHTING FACILITY PANEL (PLB)	 HIGH LEVEL 100 BCL
— LIGHTING BAR	 MID LEVEL 900-1200AFFL
— PLAIN ALU SCAFF BAR	
— CURTAIN TRACK	
⊗ D/L	
⊗ TOP FIX ANCHOR POINT WITH DESIGN LOAD	

Rev	Date	INITIAL ISSUE	Comments	Operator
P01	28.03.2024	INITIAL ISSUE		B.SANTOS

REVISION

FOR APPROVAL

CLIENT: **CRANLEIGH PARISH COUNCIL**

PROJECT: **CRANLEIGH VILLAGE HALL**

LOCATION: **CRANLEIGH**

TITLE: **HALL & STAGE GROUND FLOOR OVERVIEW PLAN**

DRAWN: G.PHILLIPS	ORIGINATOR: A.PENGELLY
CREATION DATE: 28.03.2024	SCALE: 1:100
PROJECT No.: 240416-23119-SE-101-1001	LEVEL TYPE: ROLE DWG No.
SEN. DOC REF: 23119-SE-101-1001 00	SHEET REVISION: P01

STAGE ELECTRICS

Encore House, Unit 3 Britannia Road, Patchway, Bristol, BS34 5TA
Tel: +44 (0)117 538 4000
COPYRIGHT 2024 STAGE ELECTRICS. ALL RIGHTS RESERVED. THIS WORK MUST NOT BE FURTHER DISCLOSED, REPRODUCED, MODIFIED OR BUILT WITHOUT PRIOR WRITTEN CONSENT FROM STAGE ELECTRICS.
www.stage-electrics.co.uk