


NOTES:

DO NOT SCALE

SHEET SIZE
A3


KEYPLAN

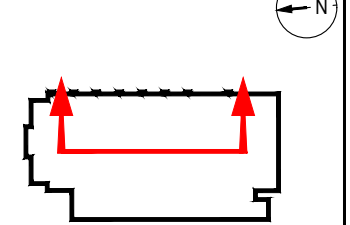

DRAWING REFERENCES

Dwg No.	Rev	Title
24865-110	--	EXISTING FLOOR PLAN

LEGEND

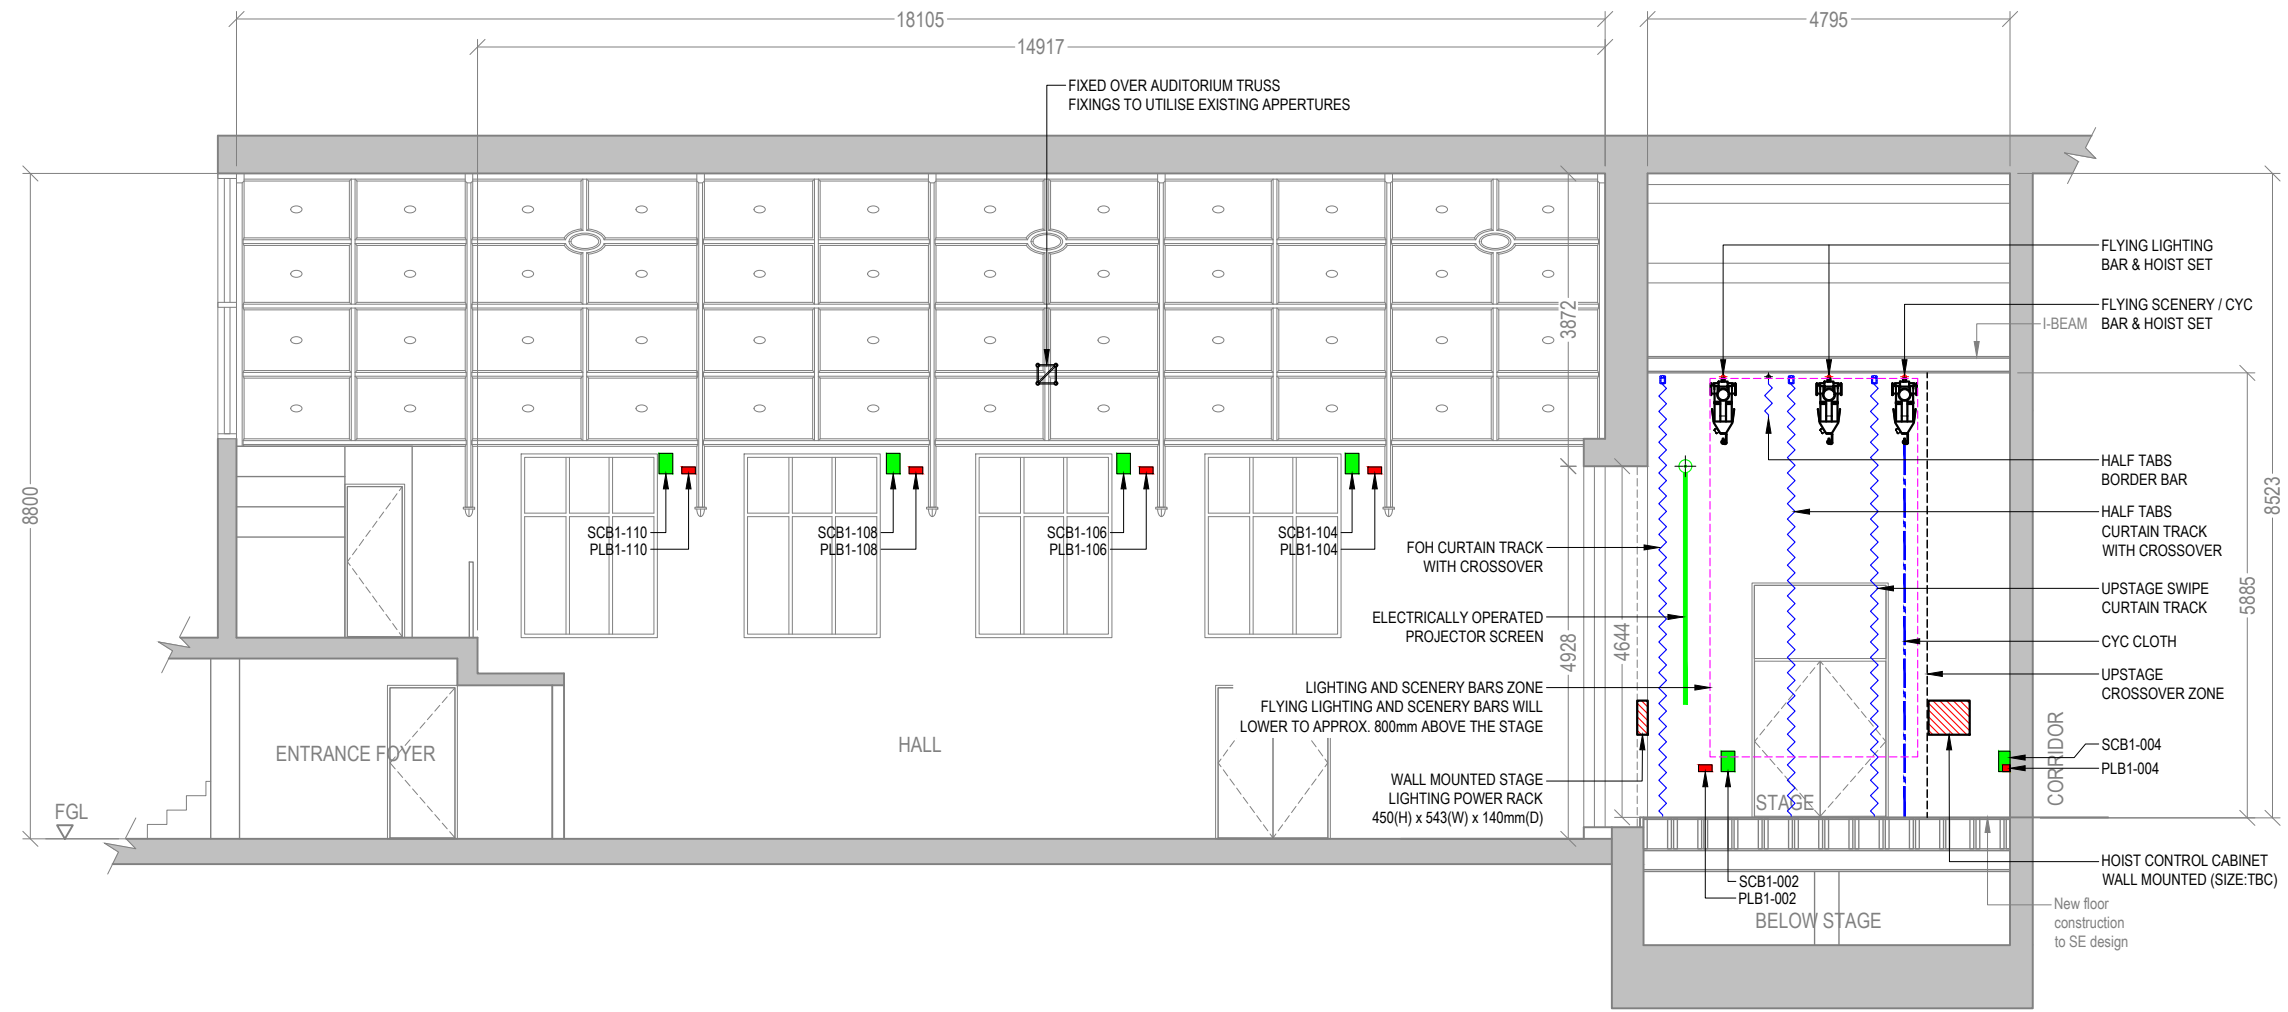

01 HALL & STAGE SECTION A-A
1:100

Rev	Date	Comments	Operator
P01	28.03.2024	INITIAL ISSUE	B.SANTOS

REVISION

FOR APPROVAL

CLIENT
CRANLEIGH PARISH COUNCIL

PROJECT
CRANLEIGH VILLAGE HALL

LOCATION
CRANLEIGH

TITLE
HALL AND STAGE SECTION DETAIL

DRAWN
A.SILI / B.SANTOS

ORIGINATOR
A.PENGELLY

CREATION DATE
28.03.2024

SCALE
1:100

PROJECT No. COMPANY ZONE LEVEL TYPE ROLE DWG No.
240416-23119-SE-104-1001

SEN. DOC REF SHEET REVISION
23119-SE-104-1001 00 P01



Encore House, Unit 3 Britannia Road, Patchway, Bristol, BS34 5TA
Tel: +44 (0)117 538 4000
COPYRIGHT 2024 STAGE ELECTRICS. ALL RIGHTS RESERVED. THIS WORK MUST NOT BE FURTHER DISCLOSED, REPRODUCED, MODIFIED OR BUILT WITHOUT PRIOR WRITTEN CONSENT FROM STAGE ELECTRICS.
www.stage-electrics.co.uk