



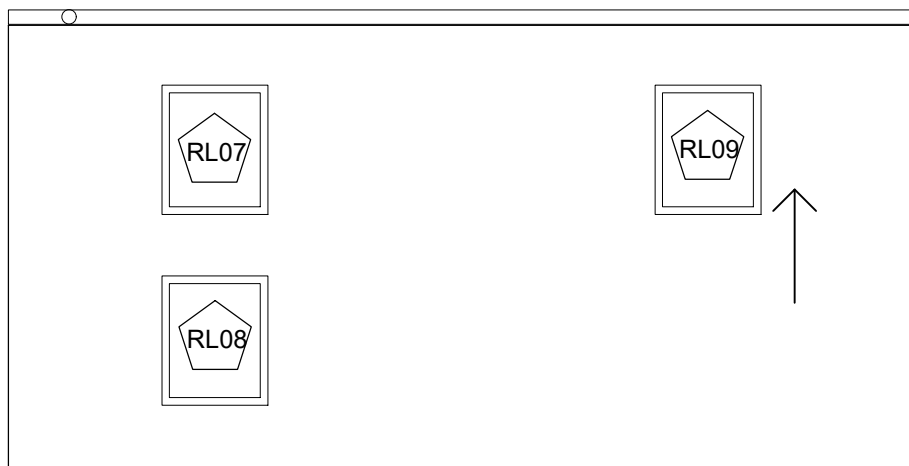

Proposed Roof Plan

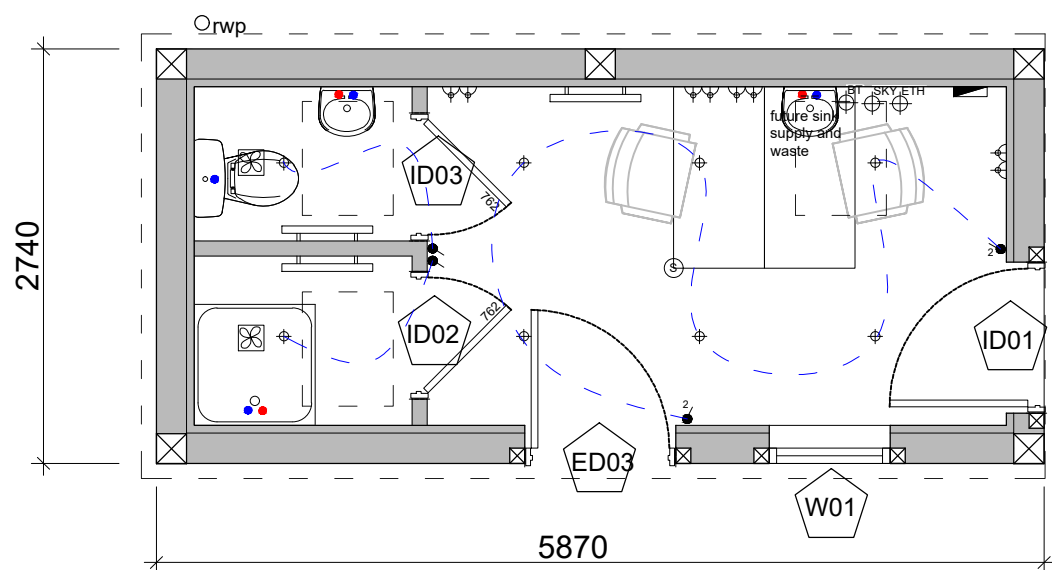


Proposed Floor Plan

BUILDING 2 - Welfare Unit
Scale 1:100

ELECTRICAL LEGEND

	EXTERNAL LIGHTING (PIR)
	PENDANT LIGHT FITTING
	RECESSED LED SPOT LIGHT FITTING
	DIRECTIONAL RECESSED LED SPOT LIGHT FITTING MIN 30° ANGLE
	WALL MOUNTED LIGHT FITTING
	WALL MOUNTED LIGHT SWITCH
	WALL MOUNTED LIGHT SWITCH 2 WAY
	SINGLE / DOUBLE SWITCHED SOCKET OUTLET
	FLOOR MOUNTED SINGLE / DOUBLE SWITCHED SOCKET OUTLET
	FUSED SPUR
	SHAVER SOCKET / TOOTHBRUSH
	RADIATOR
	TELEPHONE / SKY / ETHERNET OUTLET POINT
	TV OUTLET POINT (SKY and DIGITAL)
	CONSUMER UNIT
	SELF CONTAINED PHOTO-ELECTRIC SMOKE DETECTOR/ALARM (MAINS OPERATED & BATTERY BACK UP)
	MECHANICAL EXTRACTION CEILING MOUNTED
	MECHANICAL EXTRACT FAN THROUGH WALL
	ROOM THERMOSTAT
DW	DISHWASHER
Oven	BUILT OVEN UNIT
FF	FRIDGE FREEZER
TD	TUMBLE DRYER
WM	WASHING MACHINE
	HOT AND COLD WATER SUPPLY REQUIRED

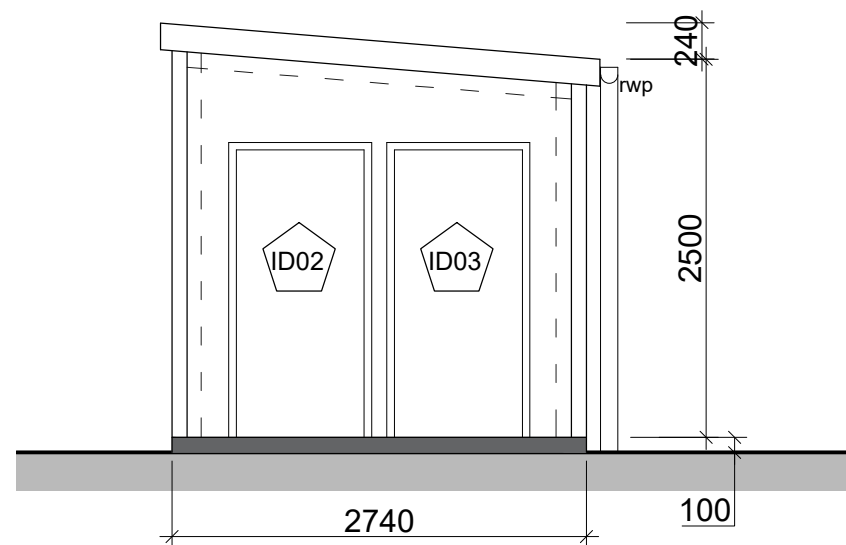

Proposed Section B-B



For Construction: Do not scale from this drawing. Figured dimensions only to be taken. Check all dimensions prior to setting out. Report all discrepancies to the Architect.

Revisions

A updated following client comment 12.10.25

CARTER DAVEY Architects LLP

T. 07525643101
E. chelsey.cda@gmail.com
davey.cda@gmail.com

Client.
Cranleigh Parish Council

Project.
Snoxhall Machine Sheds, Land at
Snoxhall Fields, Knowle Lane, GU6
8JN

Drawing Title.
BUILDING 2 - Welfare Unit - Plan
and Section
Scale.
1:50 @ A3

Date.
Sep 25

Drawing No.
25029/412

Revision.
A

< Original size 60mm - A3 at full size >