




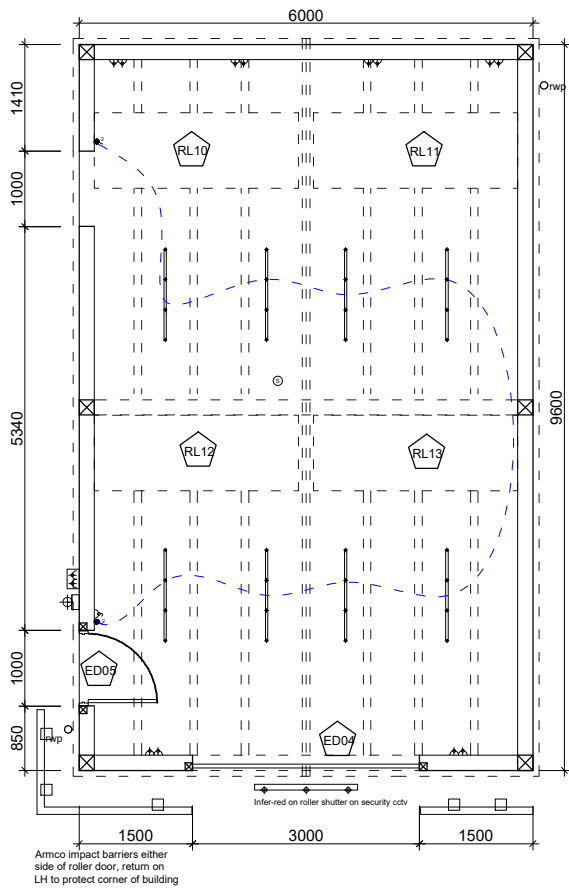

Proposed Floor Plan

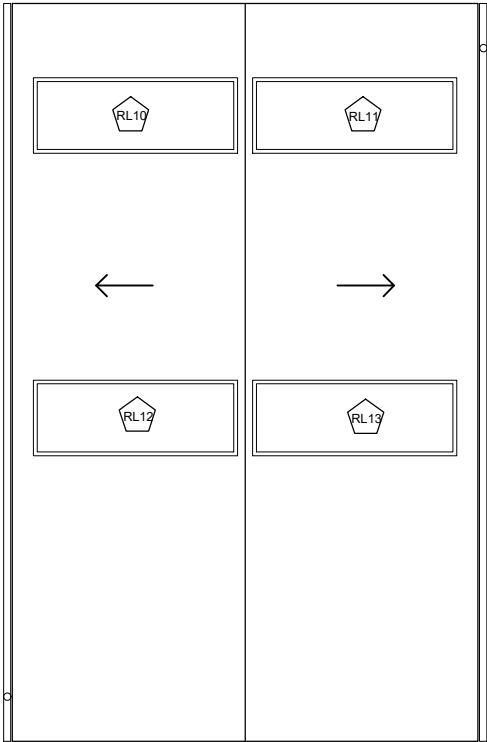

Proposed Roof Plan

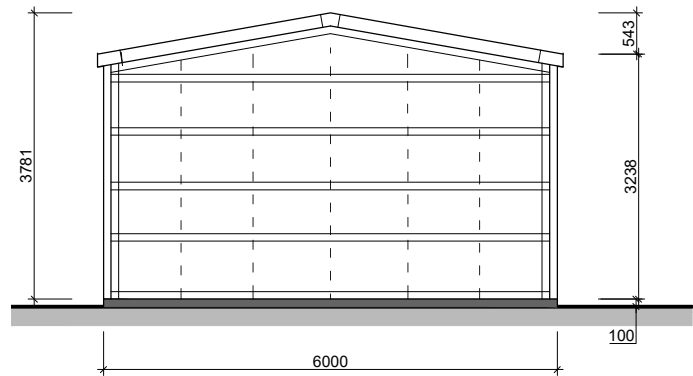

Proposed Section D-D



SCALE BAR 1:100

ELECTRICAL LEGEND

- EXTERNAL LIGHTING (PIR)
- LED STRIP LIGHTING
- RECESSED LED SPOT LIGHT FITTING
- DIRECTIONAL RECESSED LED SPOT LIGHT FITTING MIN 30° ANGLE
- WALL MOUNTED LIGHT FITTING
- WALL MOUNTED LIGHT SWITCH
- WALL MOUNTED LIGHT SWITCH 2 WAY
- SINGLE / DOUBLE SWITCHED SOCKET OUTLET
- EXTERNAL / DOUBLE SWITCHED SOCKET OUTLET
- FUSED SPUR
- SHAVR SOCKET / TOOTHBRUSH
- RADIATOR
- TELEPHONE / SKY / ETHERNET OUTLET POINT
- TV OUTLET POINT (SKY and DIGITAL)
- CONSUMER UNIT
- SELF CONTAINED PHOTO-ELECTRIC SMOKE DETECTOR/ALARM (MAINS OPERATED & BATTERY BACK UP)
- MECHANICAL EXTRACTION CEILING MOUNTED
- MECHANICAL EXTRACT FAN THROUGH WALL
- ROOM THERMOSTAT
- DW DISHWASHER
- Oven BUILT OVEN UNIT
- FF FRIDGE FREEZER
- TD TUMBLE DRYER
- WM WASHING MACHINE
- HOT AND COLD WATER SUPPLY REQUIRED

For Construction: Do not scale from this drawing. Figured dimensions only to be taken. Check all dimensions prior to setting out. Report all discrepancies to the Architect.

Revisions

- A updated following client comment 12.10.25
- B updated following client meeting 17.11.25

CARTER DAVEY Architects LLP

T. 07525643101
E. chelsey.cda@gmail.com
davey.cda@gmail.com

Client.
Cranleigh Parish Council

Project.
Snnoxhall Machine Sheds, Land at
Snnoxhall Fields, Knowle Lane, GU6
8JN

Drawing Title.
BUILDING 3 - Store & Workshop -
Plans and Section

Scale.
1:100 @ A3

Date.
Sep 25

Drawing No.
25029/414

Revision.
B

< Original size 60mm - A3 at full size >

BUILDING 3 - Store & Workshop
Scale 1:100