




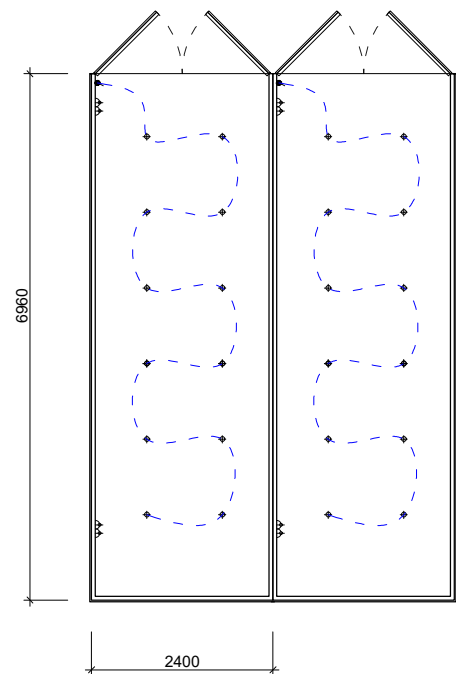


Proposed Floor Plan

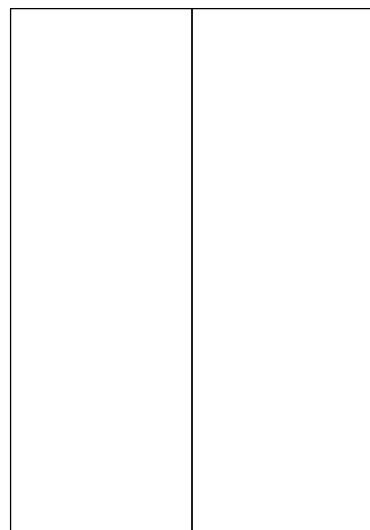


Proposed Roof Plan

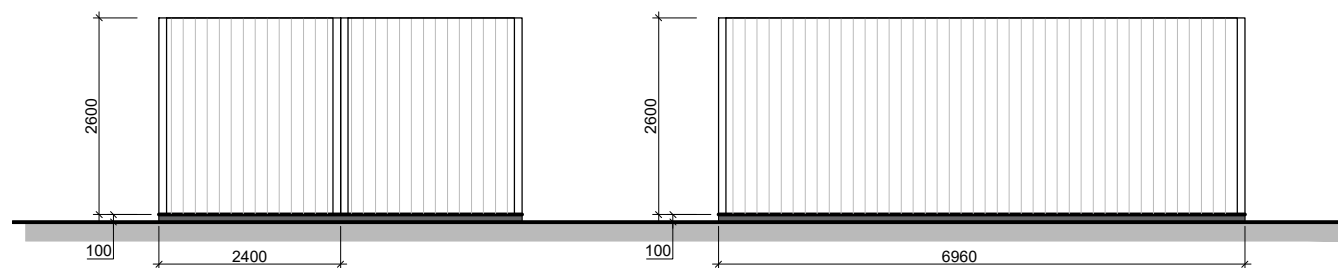


Proposed South Elevation

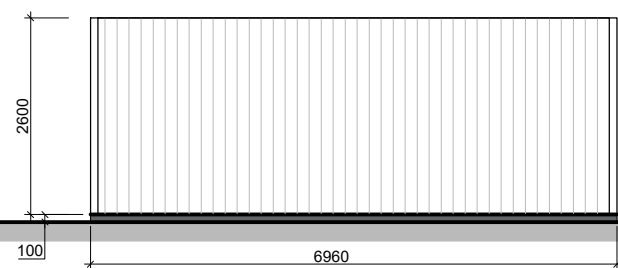

Proposed West Elevation

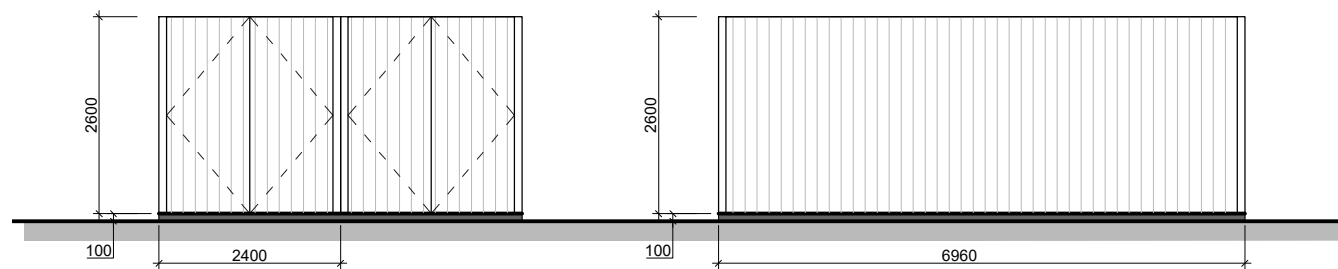

Proposed North Elevation

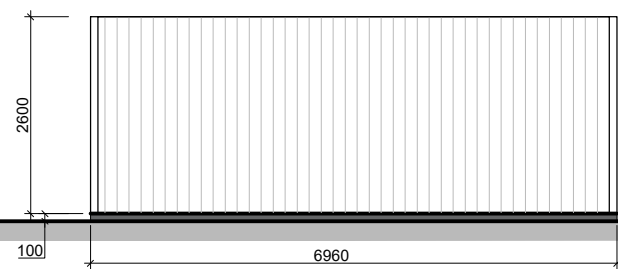

Proposed East Elevation

ELECTRICAL LEGEND

	EXTERNAL LIGHTING (PIR)
	LED STRIP LIGHTING
	RECESSED LED SPOT LIGHT FITTING
	DIRECTIONAL RECESSED LED SPOT LIGHT FITTING MIN 30° ANGLE
	WALL MOUNTED LIGHT FITTING
	WALL MOUNTED LIGHT SWITCH
	WALL MOUNTED LIGHT SWITCH 2 WAY
	SINGLE / DOUBLE SWITCHED SOCKET OUTLET
	EXTERNAL / DOUBLE SWITCHED SOCKET OUTLET
	FUSED SPUR
	SHAVER SOCKET / TOOTHBRUSH
	RADIATOR
	TELEPHONE / SKY / ETHERNET OUTLET POINT
	TV OUTLET POINT (SKY and DIGITAL)
	CONSUMER UNIT
	SELF CONTAINED PHOTO-ELECTRIC SMOKE DETECTOR/ALARM (MAINS OPERATED & BATTERY BACK UP)
	MECHANICAL EXTRACTION CEILING MOUNTED
	MECHANICAL EXTRACT FAN THROUGH WALL
	ROOM THERMOSTAT
DW	DISHWASHER
Oven	BUILT OVEN UNIT
FF	FRIDGE FREEZER
TD	TUMBLE DRYER
WM	WASHING MACHINE
	HOT AND COLD WATER SUPPLY REQUIRED

For Construction: Do not scale from this drawing. Figured dimensions only to be taken. Check all dimensions prior to setting out. Report all discrepancies to the Architect.

Revisions

A updated following client meeting 17.11.25

CARTER DAVEY Architects LLP

T. 07525643101
E. chelsey.cda@gmail.com
davey.cda@gmail.com

Client.

Cranleigh Parish Council

Project.

Snoxhall Machine Sheds, Land at
Snoxhall Fields, Knowle Lane, GU6
8JN

Drawing Title.

BUILDING 5 - Shipping Container -
Plans & Elevations

Scale.

1:100 @ A3

Date.

Sep 25

Drawing No.

25029/418

Revision.

--

< Original size 60mm - A3 at full size >

BUILDING 5 - Shipping Containers

Scale 1:100



SCALE BAR 1:100